


EXTERIOR LIGHT FIXTURE, (TYP)


 


- Architectural bronze finish.
- A Kichler tube lite design.
- Maximum 120 watt or equivalent BR40 bulb (not included).
- UL listed for wet locations.
- Dark Sky compliant.
- 7 3/4" high.
- 6" wide.
- Extends 8 1/2" from wall.
- Backplate is 5" high, 4 1/2" wide.

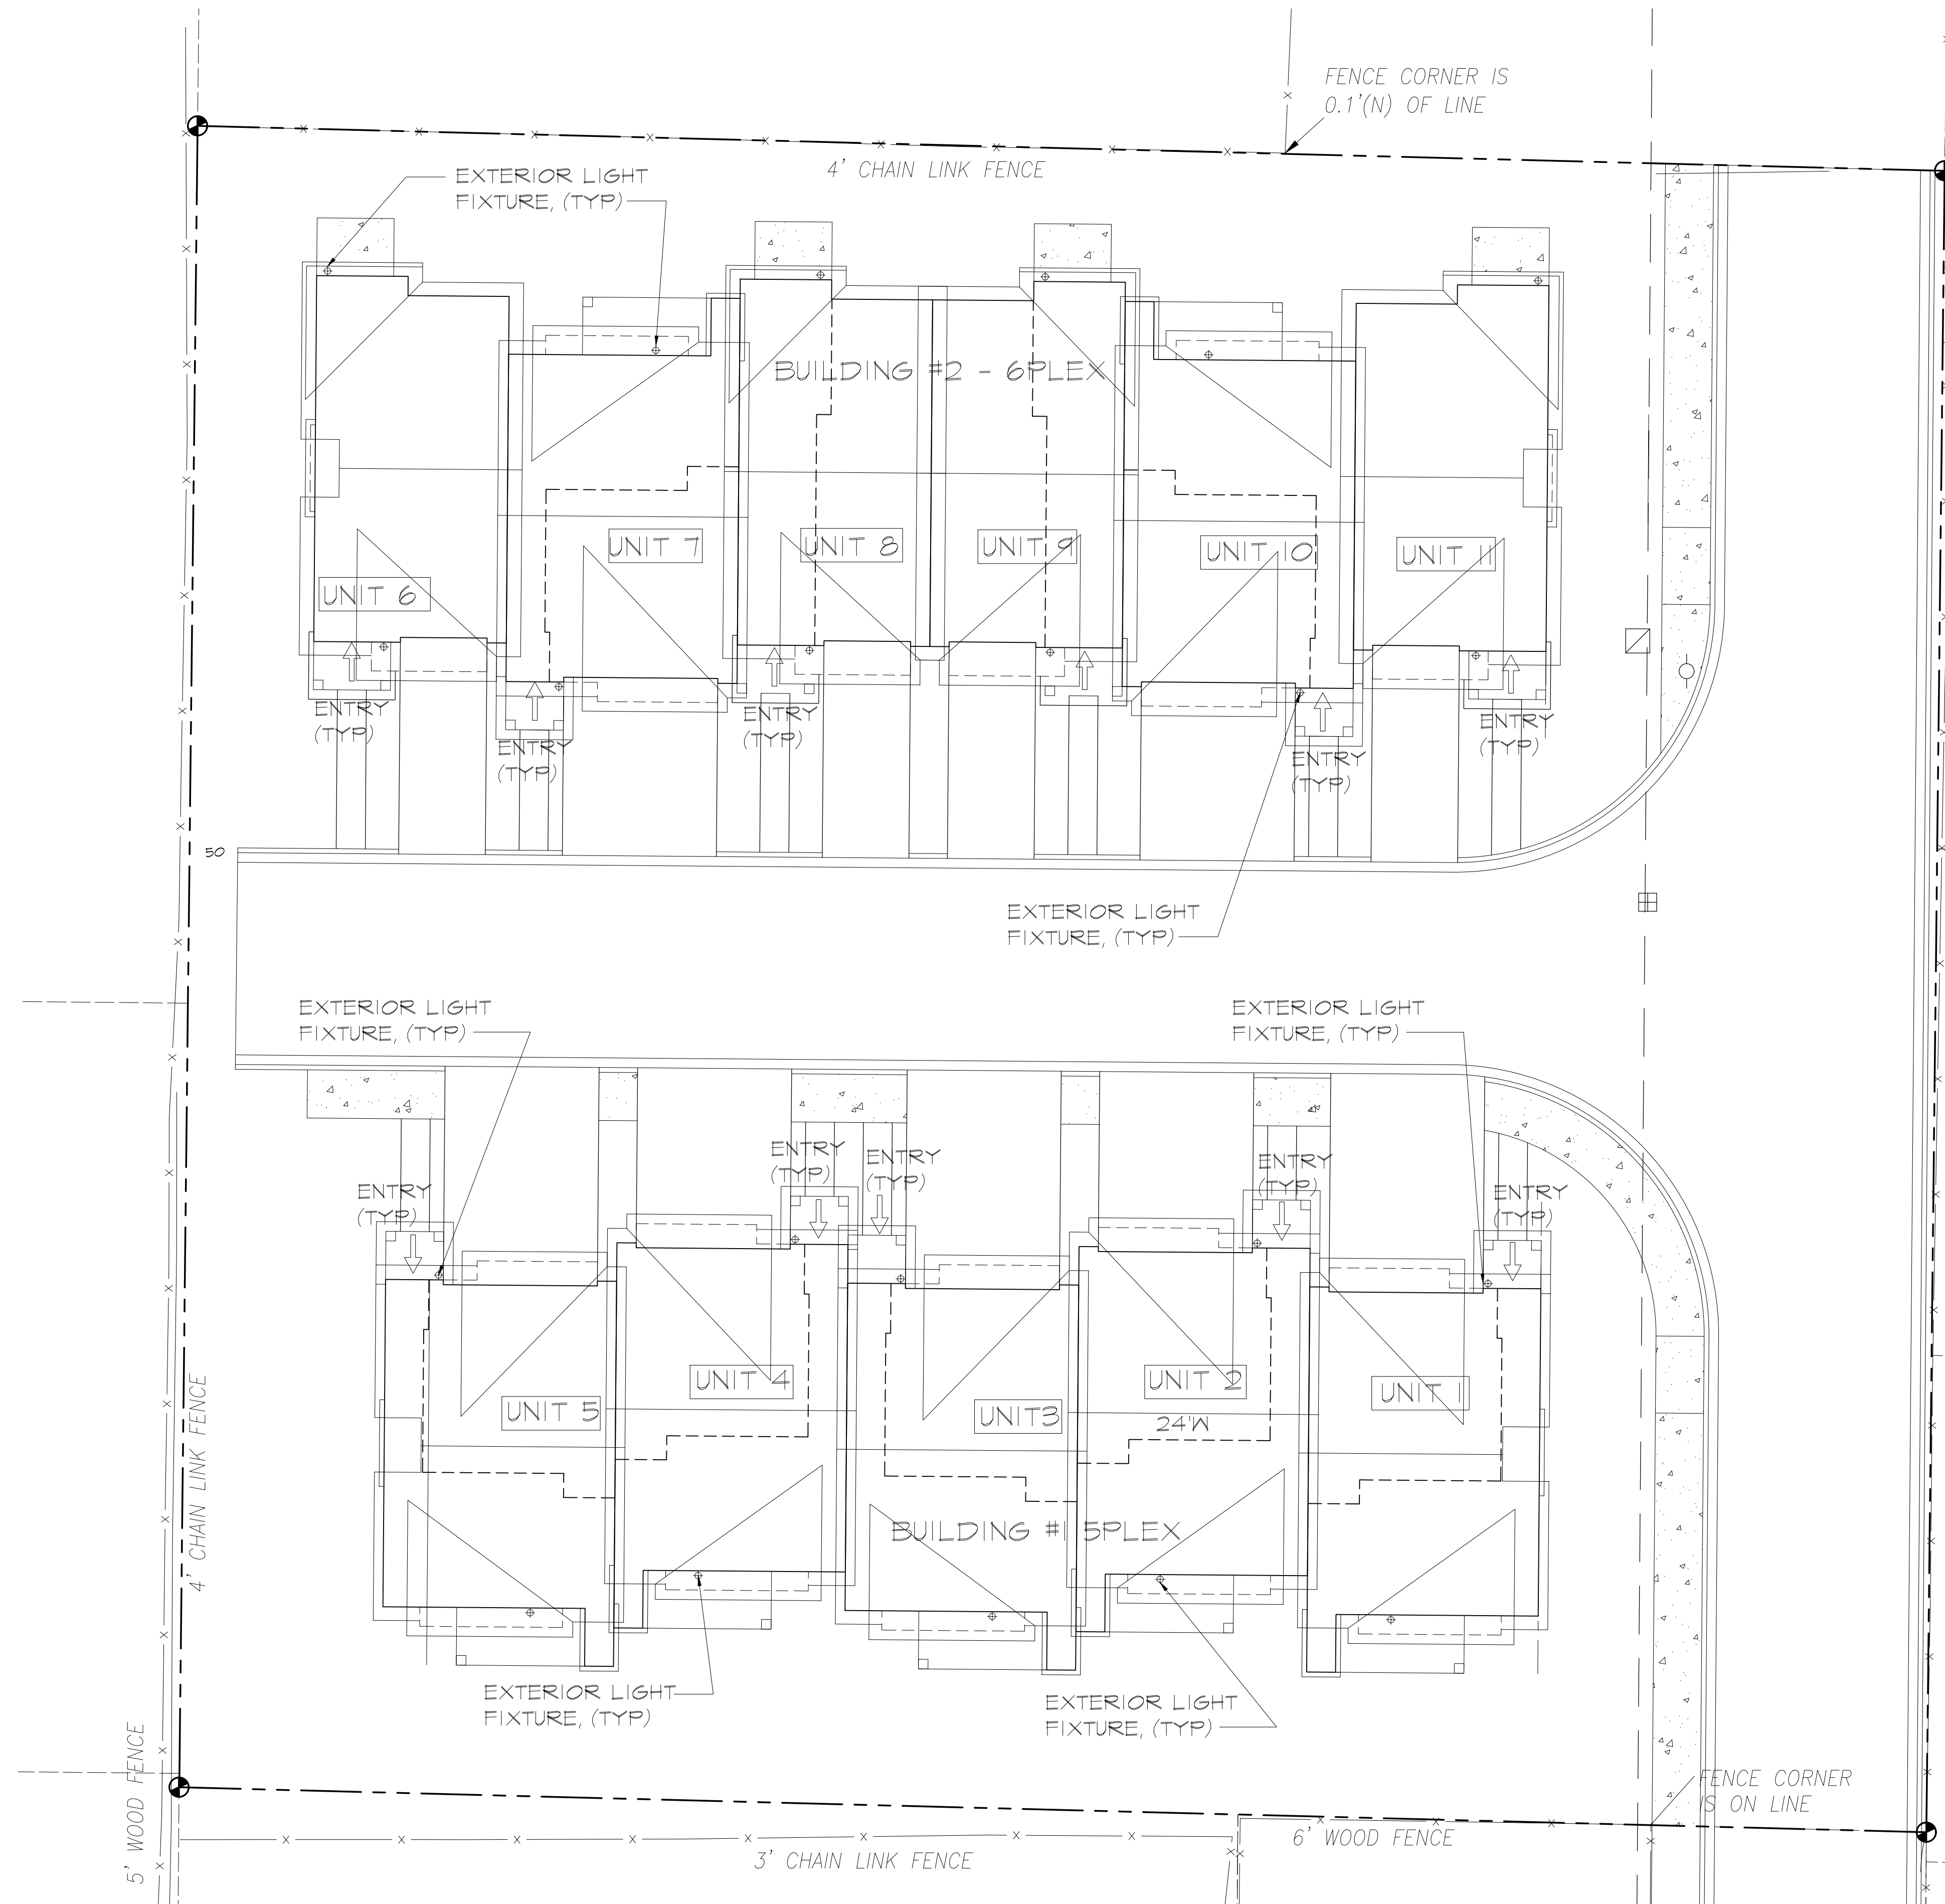

LIGHTING PLAN

SCALE: 1" = 10'-0"

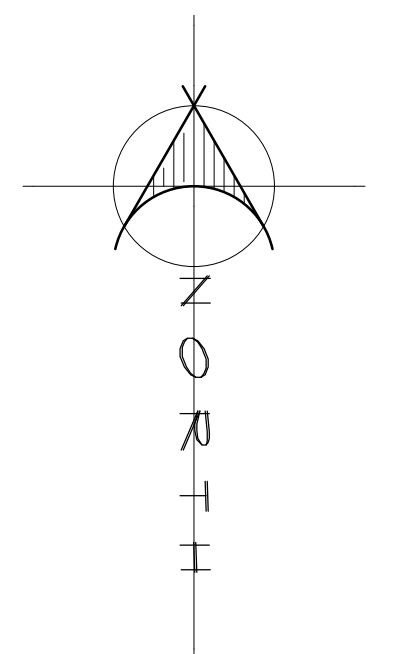

09/06/2023
CITY OF MONROE

REGISTERED ARCHITECT
JERRY P. ARDULET
STATE OF WASHINGTON
XXXX

I AM NOT PERMITTED TO USE THESE PLANS FOR ANY OTHER PROJECT WITHOUT THE WRITTEN PERMISSION OF ARCHITECTS NORTHWEST, INC. ANY REPRODUCTION OR ALTERATION OF THESE PLANS WITHOUT THE WRITTEN PERMISSION OF ARCHITECTS NORTHWEST, INC. IS PROHIBITED. THESE DRAWINGS AND PLANS SET FORTH THE DESIGN AND SHALL REMAIN THE PROPERTY OF ARCHITECTS NORTHWEST, INC.

ARCHITECTS NORTHWEST
1891B-142nd AVENUE NE SUITE 100 WOODINVILLE, WA 98072
OFFICE: (425) 485-4900 FAX: (425) 487-6885
WWW.ARCHITECTSNW.COM

PONDEROSA PACIFIC
16076 174TH DR SE, MONROE, WA 98272
11DU TH (5 PLEX + 6 PLEX)

DESIGNED BY: JdeR	DATE: 2023
DRAWN BY:	DATE:
PROJECT MANAGER: JdeR	DATE:
REVISD BY:	DATE:
LATERAL BY:	DATE:
LATERAL JOB NUMBER:	

A0.1
A4
ANW WOODINVILLE OFFICE
JOB NUMBER:
230024